



Fluorescent Tubes

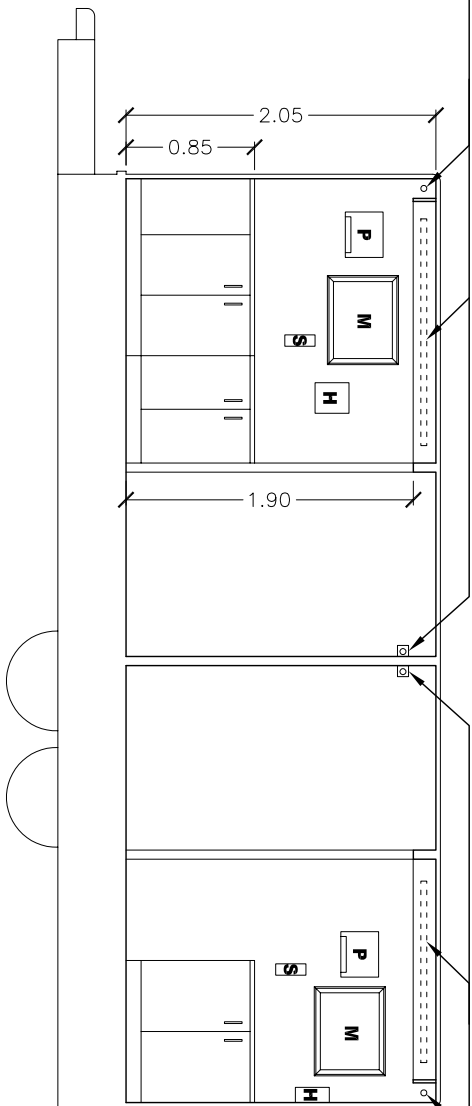


Fluorescent Tubes

SECTION-01

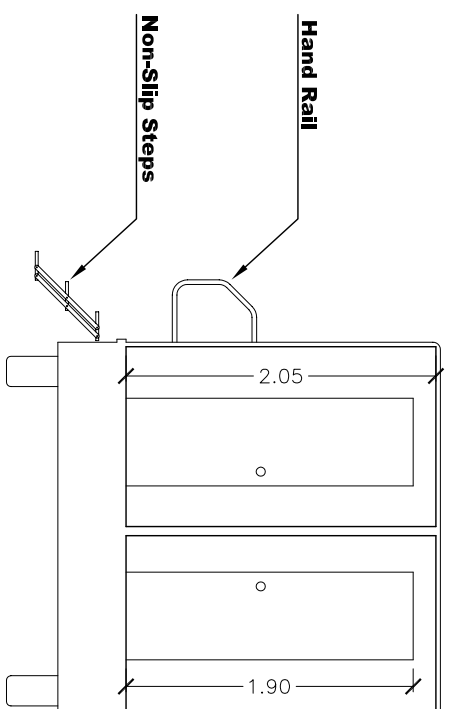


SECTION-02

© Copyright all rights reserved.

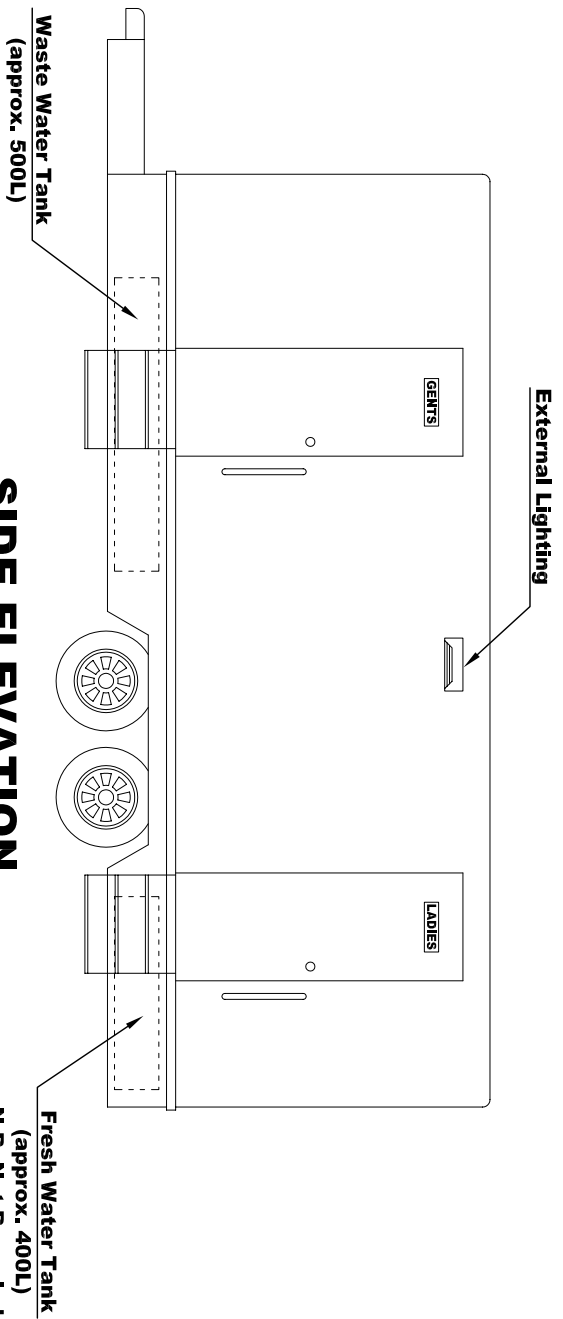


SIDE ELEVATION

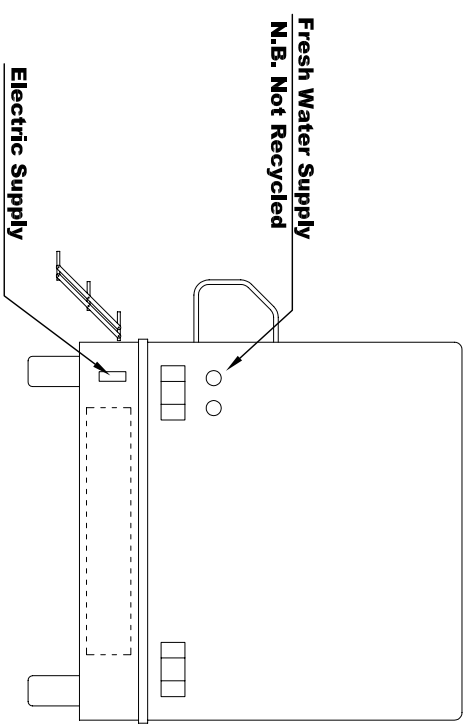


BACK ELEVATION

- P - Disposable Paper Towel Dispenser.
- S - Soap Dispenser.
- H - Hand Dryer.
- M - Mirror.

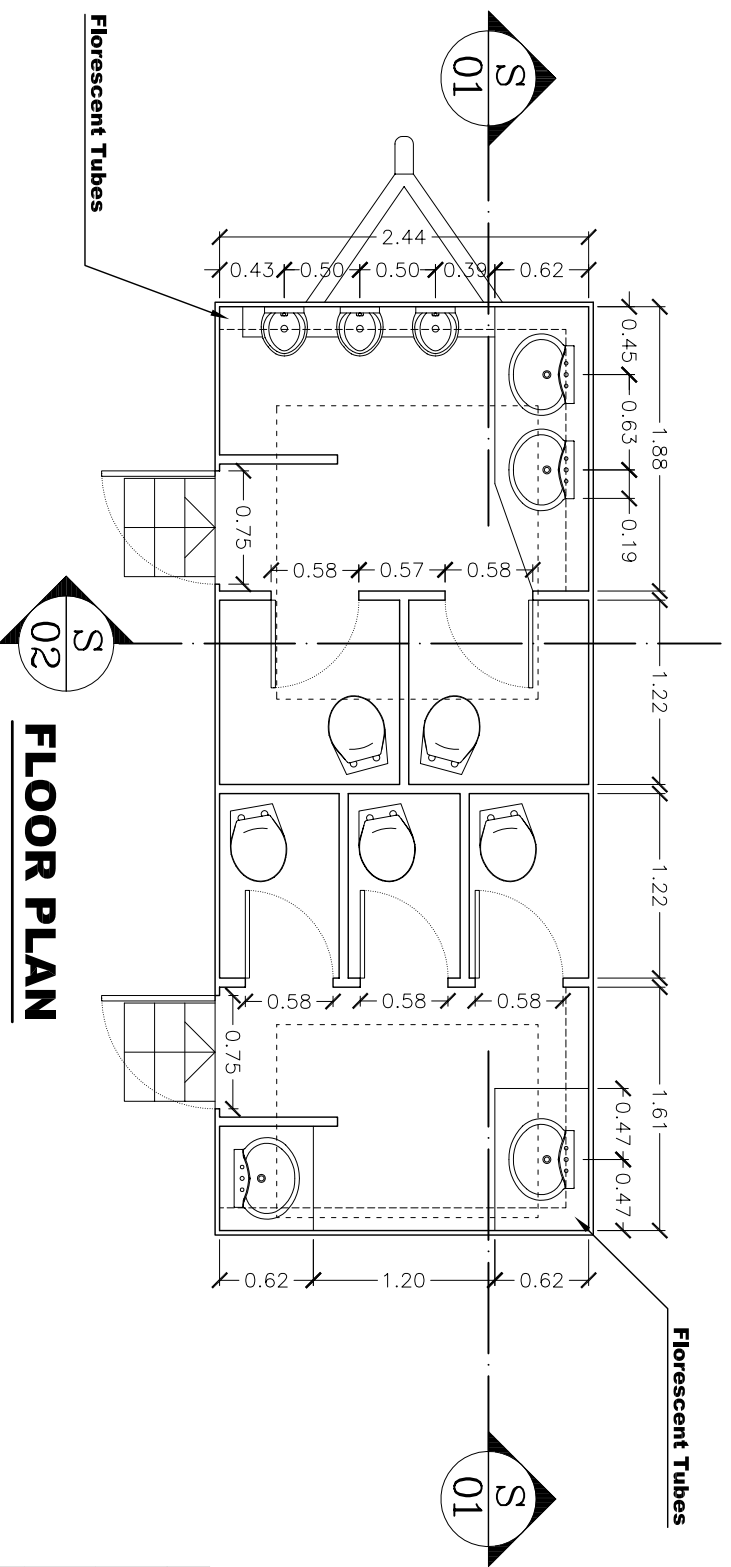

FLOOR PLAN

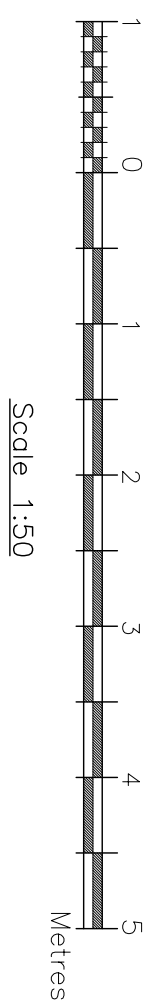

RevNo	Revision note	Date	Signature	Checked

MOBILE TOILETS TYPE-A

PLANS, SECTIONS & ELEVATIONS

Drawn by R. S.	Date 04 JUL 2009	Scale 1:50	Sheet 001	Filename GOD/2009	GOD/2009/A
-------------------	---------------------	---------------	--------------	----------------------	------------